

By adhering to these codes and standards, this HVAC plan ensures safety, efficiency, and compliance with all applicable regulations for the specified location in Fredericksburg, VA.



| MARK | SERVING | CFM | SP | WATTS | SPM | VOLTAGE | WINE MODEL | NOTES | FAN TYPE |
|------|----------|-----|----|-------|-----|----------|---------------------------|-------|----------|
| EF-1 | BATHROOM | 50 | - | 50 | 400 | 120V60Hz | Broom-Air Force 600 | | IN-LINE |
| EF-2 | KITCHEN | 375 | - | 78 | 400 | 120V60Hz | Broom-Air Force BC9013000 | | IN-LINE |

Educational Fair Schedule
 11:45 – 11:00

HVAC Legend

- Air Supply Diffuser
- Air Return Diffuser
- Air Exhaust Grill
- Air Handling Unit



| | |
|--------------------|---|
| Consultant Address | Engr. Al Arin OFFICE 24A 182-184 HIGH STREET NORTH AREA 1/1, EAST HAM LONDON UNITED KINGDOM E6 2JA |
| Email | support@engr9am.com |
| Phone | |
| Website | www.enr9am.com |


10412 Laurel Ridge Way
Fredericksburg, VA 22408

First Floor HVAC Plan

| | |
|----------------|----------------|
| Project Number | Project Number |
| Date | Issue Date |
| Drawn By | Author |
| Checked By | Checker |

H. 1

| | |
|-------|--------------|
| Scale | As indicated |
|-------|--------------|

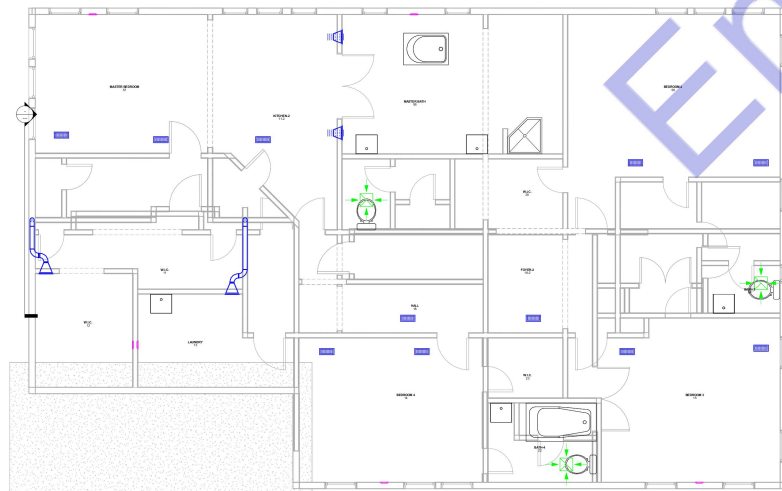

Consultant Address: Engr AJ Arin
OFFICE 24A 182-184
HIGH STREET NORTH
AREA 1/1, EAST HAM
LONDON
UNITED KINGDOM E6 2JA
Email: support@engrteam.com
Phone:
Website: www.engrteam.com

[illegible]

10412 Laurel Ridge Way
Fredericksburg, VA 22408

Second Floor HVAC Plan

| | |
|----------------|----------------|
| Project Number | Project Number |
| Date | Issue Date |
| Drawn By | Author |
| Checked By | Checker |

Scale $3/8" = 1'-0"$



Consultant Address: Engr AJ Arin
OFFICE 24A 182-184
HIGH STREET NORTH
AREA 1/1, EAST HAM
LONDON
UNITED KINGDOM E6 2JA
Email: support@engrteam.com
Phone:
Website: www.engrteam.com

Owner

10412 Laurel Ridge Way
Fredericksburg, VA 22408

3D HVAC Plan

| | |
|----------------|----------------|
| Project Number | Project Number |
| Date | Issue Date |
| Drawn By | Author |
| Checked By | Checker |

H. 3

Scale