


This electrical plan for 10412 Laurel Ridge Way, Fredericksburg, VA, has been developed in strict adherence to all applicable and updated codes and regulations. The following standards have been meticulously followed:

- ① 1 - Ceiling Elec.
300' = 1' 0"

By adhering to these updated codes and regulations, this electrical plan ensures the safety, reliability, and compliance of all electrical installations for the specified property.

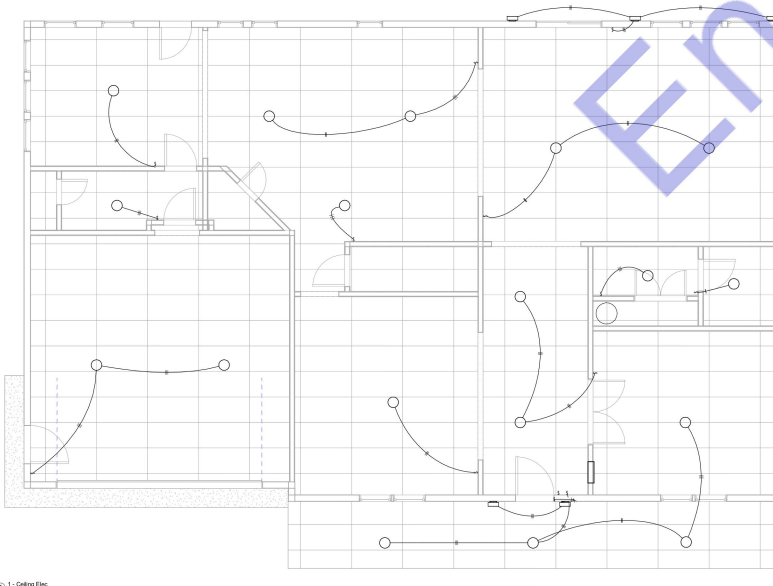

Electrical Legends
114" = 1'-0"



Consultant
Address
Email
Phone
Website

Engr Al Arrin
OFFICE 24A 182-184
HIGH STREET NORTH
AREA 1/1, EAST HAM
LONDON
UNITED KINGDOM E6 2JA
support@engrarn.com
www.engrarn.com

[illegible]

First Floor Electrical Lighting Plan

Project Number	Project Number
Date	Issue Date
Drawn By	Author
Checked By	Checker

E. 1

Scale	As indicated
-------	--------------



Electrical Legend
144 - 11/08



Scale	As indicated
-------	--------------

By adhering to these codes and standards, this HVAC plan ensures safety, efficiency, and compliance with all applicable regulations for the specified location in Fredericksburg, VA.



MARK	SERVING	CFM	SP	WATTS	RPM	VOLTAGE	MAKE MODEL	NOTES	FAN TYPE
EF-1	BATHROOM	50	-	50	400	120V60	GreenAir Force 006		ON-LINE
EF-2	KITCHEN	375	-	78	400	120V60	GreenAir Force BC9013000		ON-LINE

○ Exhaust Fan Schedule
1/4" = 1'-0"

HVAC Legend

- Air Supply Diffuser
- Air Return Diffuser
- Air Exhaust Grill
- Air Handling Unit



Consultant	Engr. Al Arin
Address	OFFICE 24A 182-184 HIGH STREET NORTH AREA 1/1, EAST HAM LONDON UNITED KINGDOM E6 2JA
Email	support@engr9am.com
Phone	
Website	www.engr9am.com

[illegible]


10412 Laurel Ridge Way
Fredericksburg, VA 22408

First Floor HVAC Plan

Project Number	Project Number
Date	Issue Date
Drawn By	Author
Checked By	Checker

H. 1

Scale	As indicated
-------	--------------

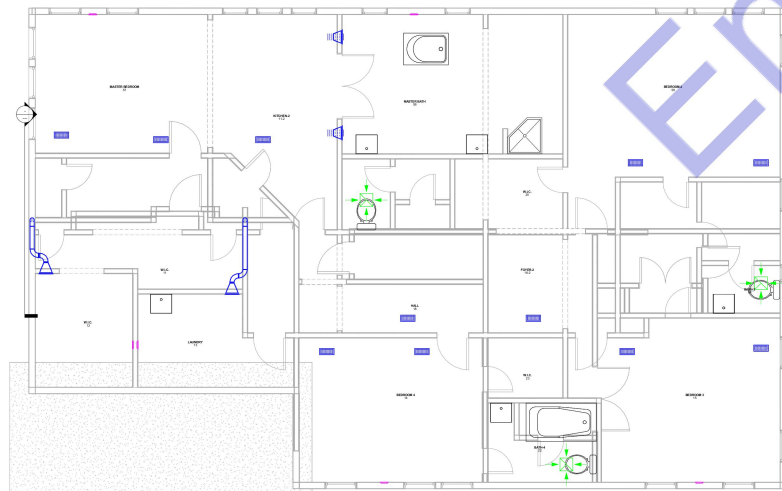

Consultant
Address
Engr AJ Arrin
OFFICE 24A 182-184
HIGH STREET NORTH
AREA 1/1, EAST HAM
LONDON
UNITED KINGDOM E6 2JA
support@engrteam.com

Email
Phone
Website
www.engrteam.com

[illegible]

10412 Laurel Ridge Way
Fredericksburg, VA 22408

Second Floor HVAC Plan

Project Number	Project Number
Date	Issue Date
Drawn By	Author
Checked By	Checker

Scale $3/8" = 1'-0"$



Consultant
Address
Engr AJ Arrin
OFFICE 24A 182-184
HIGH STREET NORTH
AREA 1/1, EAST HAM
LONDON
UNITED KINGDOM E6 2JA
support@engrteam.com

Email
Phone
Website
www.engrteam.com

Owner

10412 Laurel Ridge Way
Fredericksburg, VA 22408

3D HVAC Plan

Project Number	Project Number
Date	Issue Date
Drawn By	Author
Checked By	Checker


H. 3

Scale

This plumbing plan for 10412 Laurel Ridge Way, Fredericksburg, VA, has been developed in strict adherence to the latest applicable codes and regulations to ensure safety, functionality, and compliance. The following codes and standards have been meticulously followed:

- By integrating these codes and standards, this plumbing plan aims to deliver a system that is safe, efficient, and fully compliant with all regulatory requirements.

① 1. Fluménz
2001 - 41.00

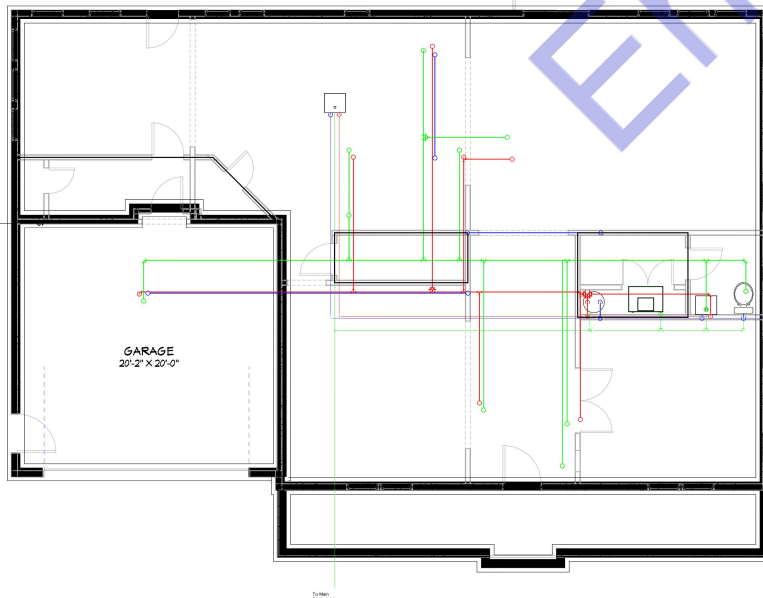

www.engteam.com

Consultant Engr Al Arin
Address OFFICE 24A 182-184
HIGH STREET NORTH
AREA 1/1, EAST HAM
LONDON
UNITED KINGDOM E6 2JA
support@engrinarin.com
Email
Phone
Website www.enrteam.com

[illegible]

Owner


10412 Laurel Ridge Way
Fredericksburg, VA 22408

First Floor Plumbing Plan

Project Number	Project Number
Date	Issue Date
Drawn By	Author
Checked By	Checker

P. 1

Scale	As indicated
-------	--------------

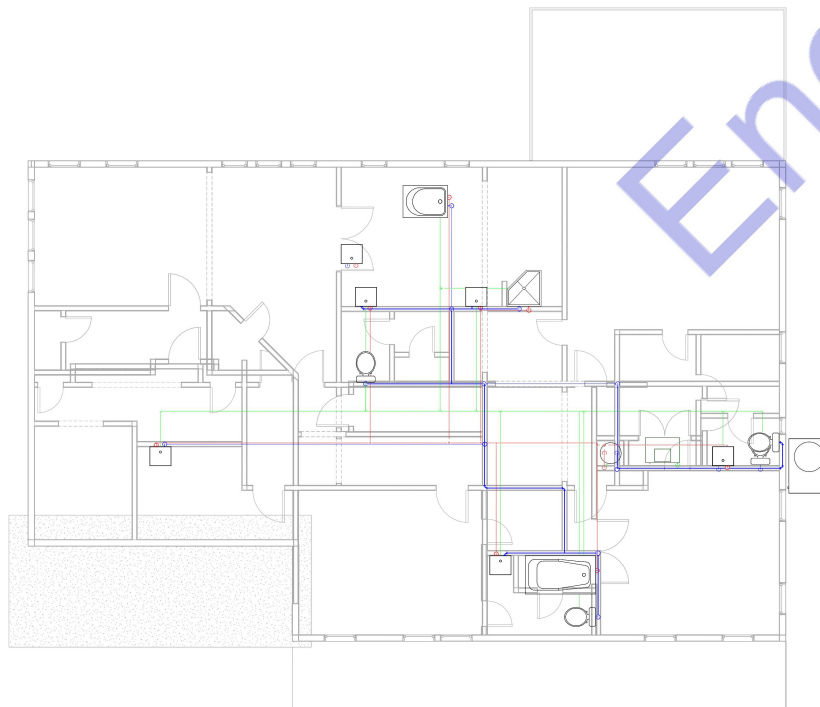

Consultant
Address
Engr AJ Arrin
OFFICE 24A 182-184
HIGH STREET NORTH
AREA 1/1, EAST HAM
LONDON
UNITED KINGDOM E6 2JA
support@engrteam.com

Email
Phone
Website
www.engrteam.com

[illegible]

Owner

10412 Laurel Ridge Way
Fredericksburg, VA 22408

Second Floor Plumbing Plan

Project Number	Project Number
Date	Issue Date
Drawn By	Author
Checked By	Checker

P. 2

Scale $3/8" = 1'-0"$

1	2	3	100
---	---	---	---	---	---	---	---	---	----	----	-----