 


Project Number	Project Number
Date	Issue Date
Drawn By	Author
Checked By	Checker
P. 1	
Scale	3/8" = 1'-0"



3/10/2025 4:18:29 PM



Consultant Address	Ditchamol OFFICE 24A 182-184 HIGH STREET NORTH AREA 1/1, EAST HAM LONDON UNITED KINGDOM E6 2JA
Email	support@engrteam.com
Phone	
Website	www.engrteam.com

[illegible]

Owner

Goatbarn Lane, Boulder, Colorado  
80302

3D Plumbing Plan

Project Number	Project Number
----------------	----------------

Project Number	Project Number
Date	Issue Date

Drawn By	Author
----------	--------


Drawn By	Author
Checked By	Checker

---

P. 3

Scale	
-------	--

r		
---	--	--

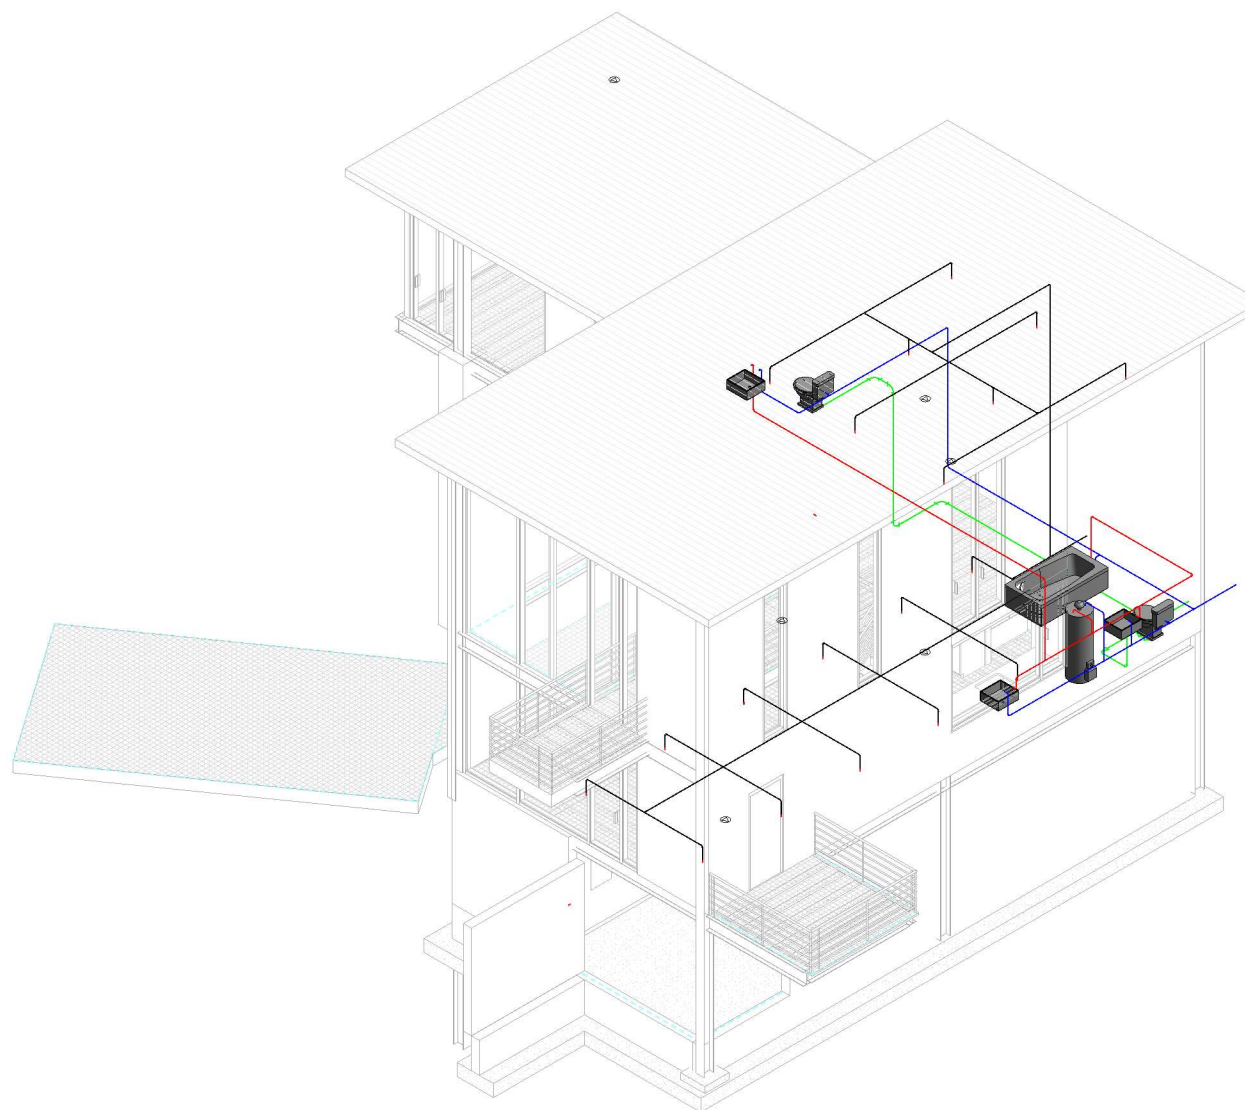

### ① 3D Plumbing