



## ENGINEER'S TEAM

430 E 8TH ST STE 8017  
HOLLAND MI 49423

ENGRTEAM.COM

SUPPORT@ENGRTEAM.COM

OWNER:

Home

SEAL:

Release for construction

ELECTRICAL  
LIGHTING PLAN

Drawn by: Engr. Al Amin

|           |                 |
|-----------|-----------------|
| Drawn by: | Eng. / A. / ... |
| Checked:  |                 |

|          |          |
|----------|----------|
| Checked: |          |
| Date:    | DEC, 24. |

E. 1

Scale: 1:100



## ENGINEER'S TEAM

430 E 8TH ST STE 8017  
HOLLAND MI 49423

ENGRTEAM.COM

SUPPORT@ENGRTEAM.COM

### OWNER:

Home  
Larnaca, Cyprus

### SEAL:

Release for construction

### ELECTRICAL POWER PLAN

Drawn by: Engr. Al Amin


Checked:

Date: DEC, 24.


E. 2

Scale: 1:100

| ELECTRICAL LEGEND |                            |
|-------------------|----------------------------|
|                   | 120V Single Phase 1-Wire   |
|                   | 120V Single Phase 2-Wire   |
|                   | 240V Single Phase 2-Wire   |
|                   | 240V Single Phase 3-Wire   |
|                   | 240V Single Phase 4-Wire   |
|                   | 240V Single Phase 5-Wire   |
|                   | 240V Single Phase 6-Wire   |
|                   | 240V Single Phase 7-Wire   |
|                   | 240V Single Phase 8-Wire   |
|                   | 240V Single Phase 9-Wire   |
|                   | 240V Single Phase 10-Wire  |
|                   | 240V Single Phase 11-Wire  |
|                   | 240V Single Phase 12-Wire  |
|                   | 240V Single Phase 99-Wire  |
|                   | 240V Single Phase 100-Wire |

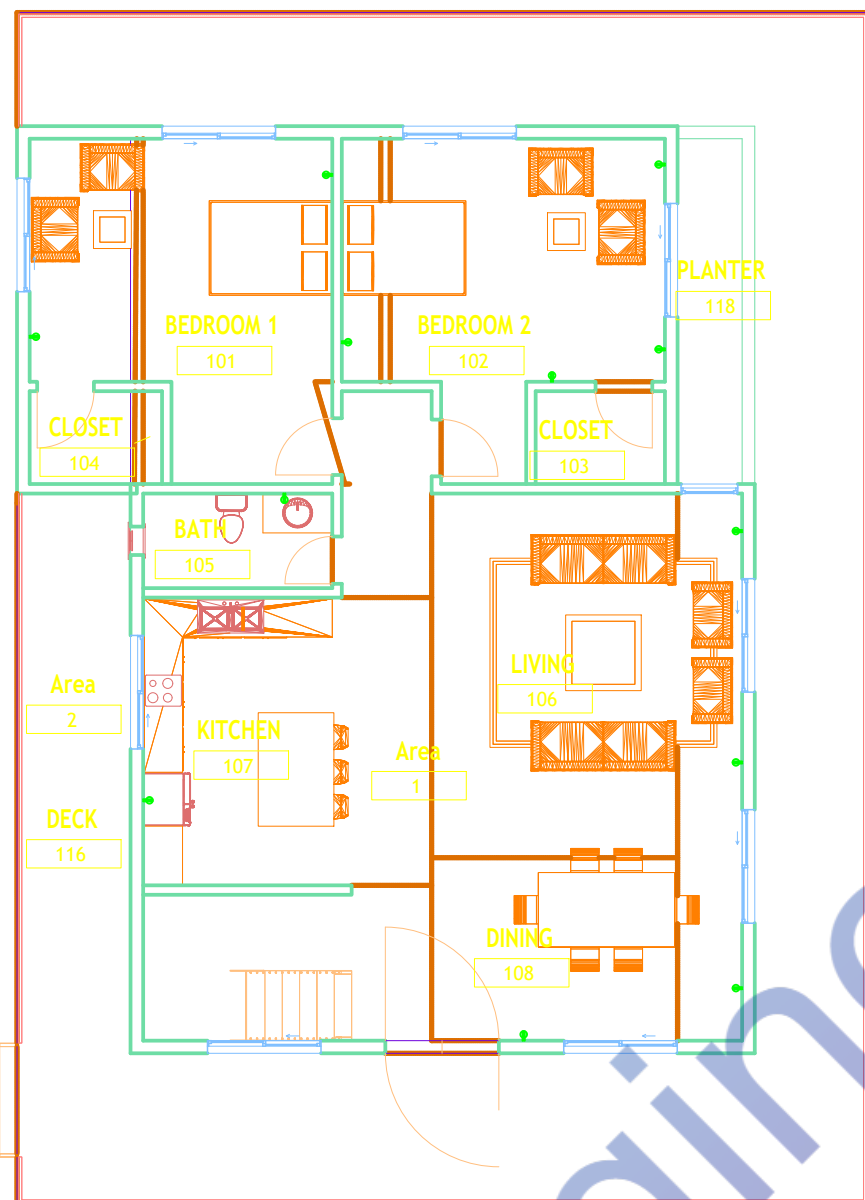

FIRST FLOOR PLAN

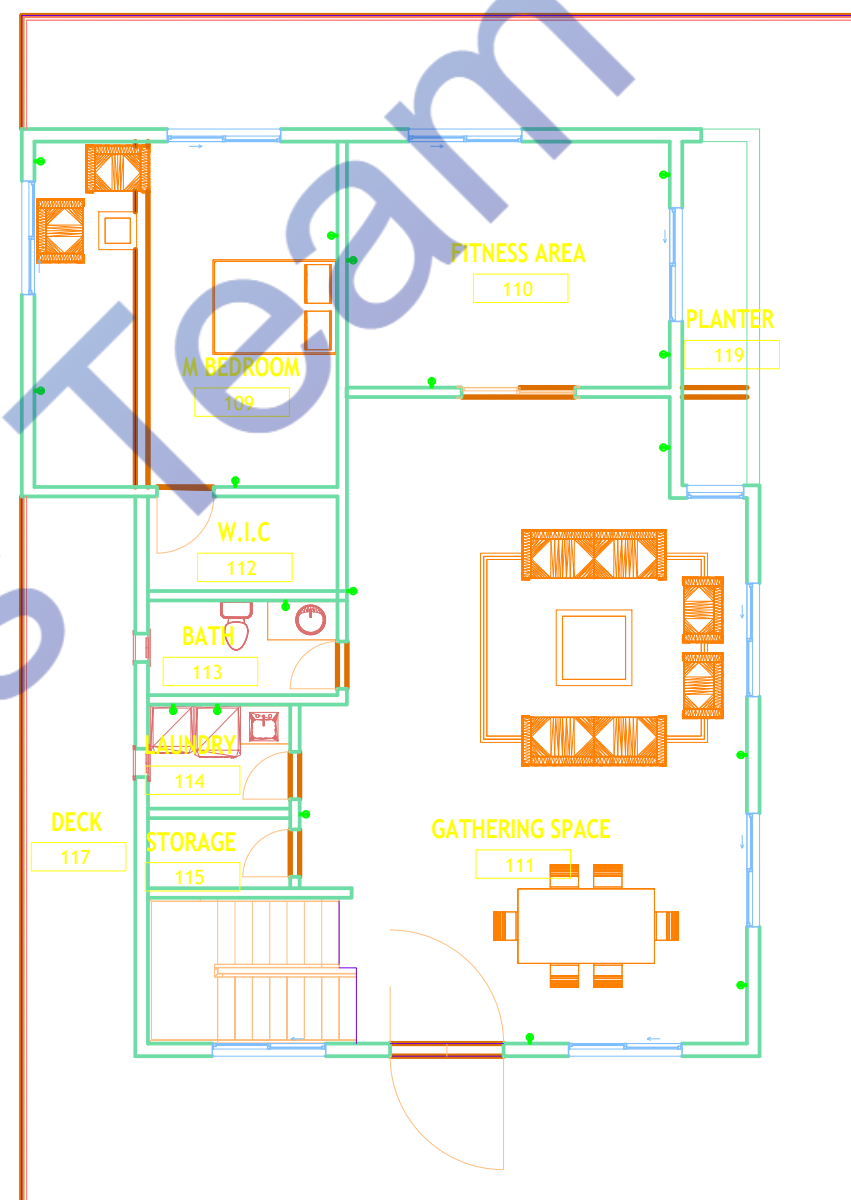

SECOND FLOOR PLAN