

By adhering to these codes and standards, this HVAC plan ensures safety, efficiency, and compliance with all applicable regulations for the specified location in Fredericksburg, VA.



MARK	SERVING	CFM	SP	WATTS	SPM	VOLTAGE	WINE MODEL	NOTES	FAN TYPE
EF-1	BATHROOM	50	-	50	400	120V60Hz	Broom-Air Force 600		IN-LINE
EF-2	KITCHEN	375	-	78	400	120V60Hz	Broom-Air Force BC9013000		IN-LINE

Educational Fair Schedule
 11:45 – 11:00

HVAC Legend

- Air Supply Diffuser
- Air Return Diffuser
- Air Exhaust Grill
- Air Handling Unit



Consultant Address	Engr. Al Arin OFFICE 24A 182-184 HIGH STREET NORTH AREA 1/1, EAST HAM LONDON UNITED KINGDOM E6 2JA
Email	support@engr9am.com
Phone	
Website	www.engr9am.com


10412 Laurel Ridge Way
Fredericksburg, VA 22408

First Floor HVAC Plan

Project Number	Project Number
Date	Issue Date
Drawn By	Author
Checked By	Checker

H. 1

Scale	As indicated
-------	--------------

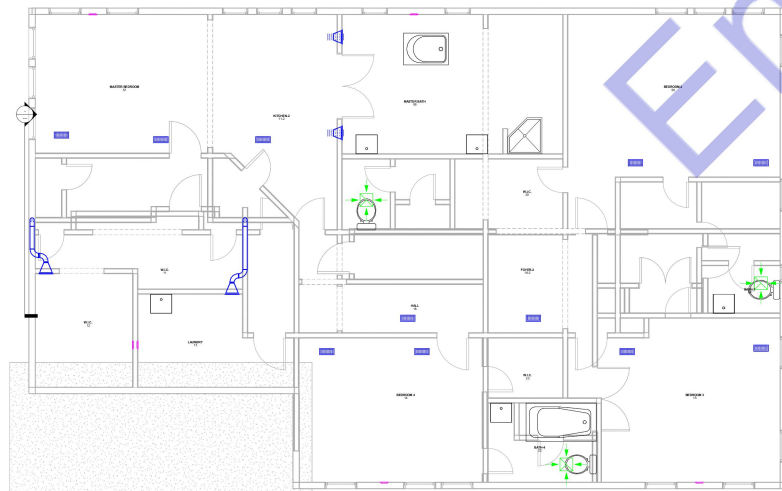

Consultant Address	Engr AJ Arrin OFFICE 24A 182-184 HIGH STREET NORTH AREA 1/1, EAST HAM LONDON UNITED KINGDOM E6 2JA support@engrteam.com
Email	
Phone	
Website	www.engrteam.com

[illegible]

10412 Laurel Ridge Way
Fredericksburg, VA 22408

Second Floor HVAC Plan

Project Number	Project Number
Date	Issue Date
Drawn By	Author
Checked By	Checker

Scale $3/8" = 1'-0"$



Consultant Address: Engr AJ Arin
OFFICE 24A 182-184
HIGH STREET NORTH
AREA 1/1, EAST HAM
LONDON
UNITED KINGDOM E6 2JA
support@engrteam.com

Email: support@engrteam.com

Phone: www.engrteam.com

Website: www.engrteam.com

Owner

10412 Laurel Ridge Way
Fredericksburg, VA 22408

3D HVAC Plan

Project Number	Project Number
Date	Issue Date
Drawn By	Author
Checked By	Checker

H. 3

Scale



Designed By Engr. Al Amin (MEP Engineer | Director - Engineer's Team LTD)

 support@engrteam.com

 <https://engrteam.com>

OUR SERVICES:

- MEP Plan Services
- HVAC Layout Plan
- Electrical Engineering Services
- Plumbing Engineering Services
- Fire protection & Security systems
- Specialized services

INFORMATION:

- Studio
- Contact Us
- Gift cards
- Privacy Policy
- Refund Policy
- Delivery Policy