

"Pumping Plan Compliance Statement"

1. "2021 Virginia Uniform Statewide Building Code (USBC)": Effective January 18, 2024, this code governs all aspects of building construction and maintenance within Virginia. cite: [turnsearch0](#)

3. "2021 International Residential Code (IRC)": Applicable to one- and two-family dwellings, the IRC includes plumbing provisions relevant to residential

5. "2021 International Energy Conservation Code (IECC)"; Establishes minimum requirements for energy-efficient buildings, including plumbing system considerations. *note:* [Ium0search0](#)

7. **2020 National Electrical Code (NEC)**: Sets standards for electrical wiring and equipment, pertinent to electrically operated plumbing devices.

9. "Code of Virginia Asbestos Regulations (36-99.7, USBC 110.3)": Regulates the handling of asbestos-containing materials during construction or renovation
cde.tumiasarch0

11. "VA, USA Product Approval Codes": All plumbing products and materials specified in this plan have been selected based on their compliance with Virginia's product approval requirements, ensuring they meet established safety and performance standards.

By integrating these codes and standards, this plumbing plan aims to deliver a system that is safe, efficient, and fully compliant with all regulatory requirements.

Owner

10412 Laurel Ridge Way
Fredericksburg, VA 22408

First Floor Plumbing Plan

Project Number	Project Number
----------------	----------------

Date	Issue Date
------	------------

Drawn By	Author
----------	--------

Checked By	Checker
------------	---------


D 1

P. 1

Scale As indicated

P. 1

As indicated

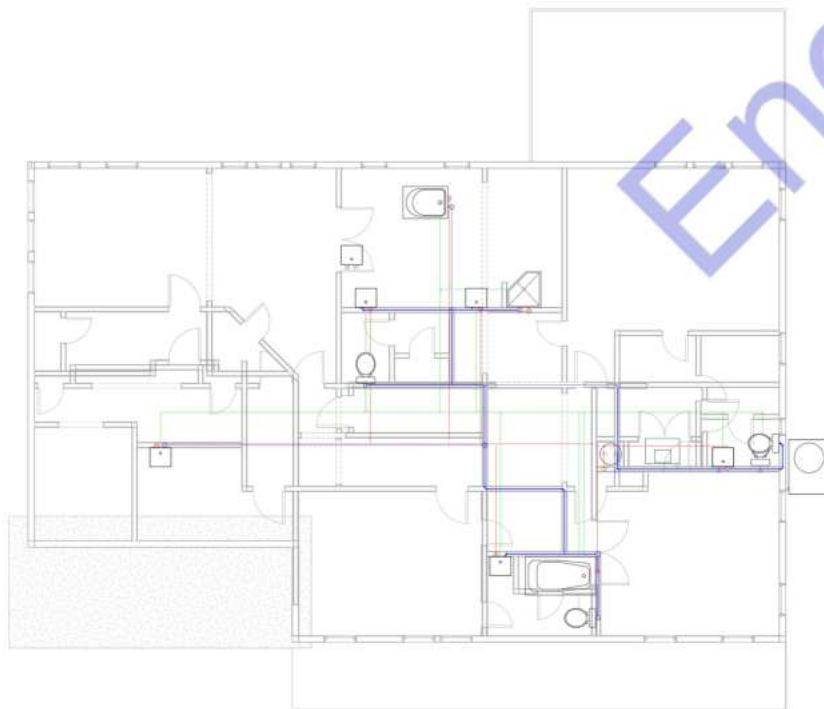

Consultant: Roger M. Adams
Address: OFFICE 200A TCU-189
HOGAN STREET NORTON
ARIZONA 85501-4944
USA
Email: support@emglight.com
Phone:
Website: www.emglight.com

[illegible]

Owner

10412 Laurel Ridge Way
Fredericksburg, VA 22408

Second Floor Plumbing Plan

Project Number	Project Number
Date	Issue Date
Drawn By	Author
Checked By	Checker

P. 2

Scale	3/8" = 1'-0"
-------	--------------



Designed By Engr. Al Amin (MEP Engineer | Director - Engineer's Team LTD)



support@engrteam.com



<https://engrteam.com>

OUR SERVICES:

- MEP Plan Services
- HVAC Layout Plan
- Electrical Engineering Services
- Plumbing Engineering Services
- Fire protection & Security systems
- Specialized services

INFORMATION:

- Studio
- Contact Us
- Gift cards
- Privacy Policy
- Refund Policy
- Delivery Policy